


SPECIALTY	NAME	DATE	SPECIALTY	NAME	DATE
BUILDING STRUCTURE			HEATING AND VENTILATION		
WATER SYSTEM			ELECTRIC		
			PLUM CURRENT		

LIDA GROUP
Weifang Henglida Steel Structure Co., Ltd.
Add: 5th Floor, Building A, Darron Center,
NO.100, Haier Road, Qingdao City, 266000, China.
TEL: 86-532-88969882 FAX: 86-532-88965571
WEB SITE: www.lidajituan.com

Remarks:
1. All rights of the figure reserved for my company, no modification will be allowed without our company's written authorization.
2. All the design, conception and information of the figure will only applied for designated project, no other application will be allowed without our company's written authorization.
3. The figure can be used as manufacture bases only after the review and approval by the relevant management department.

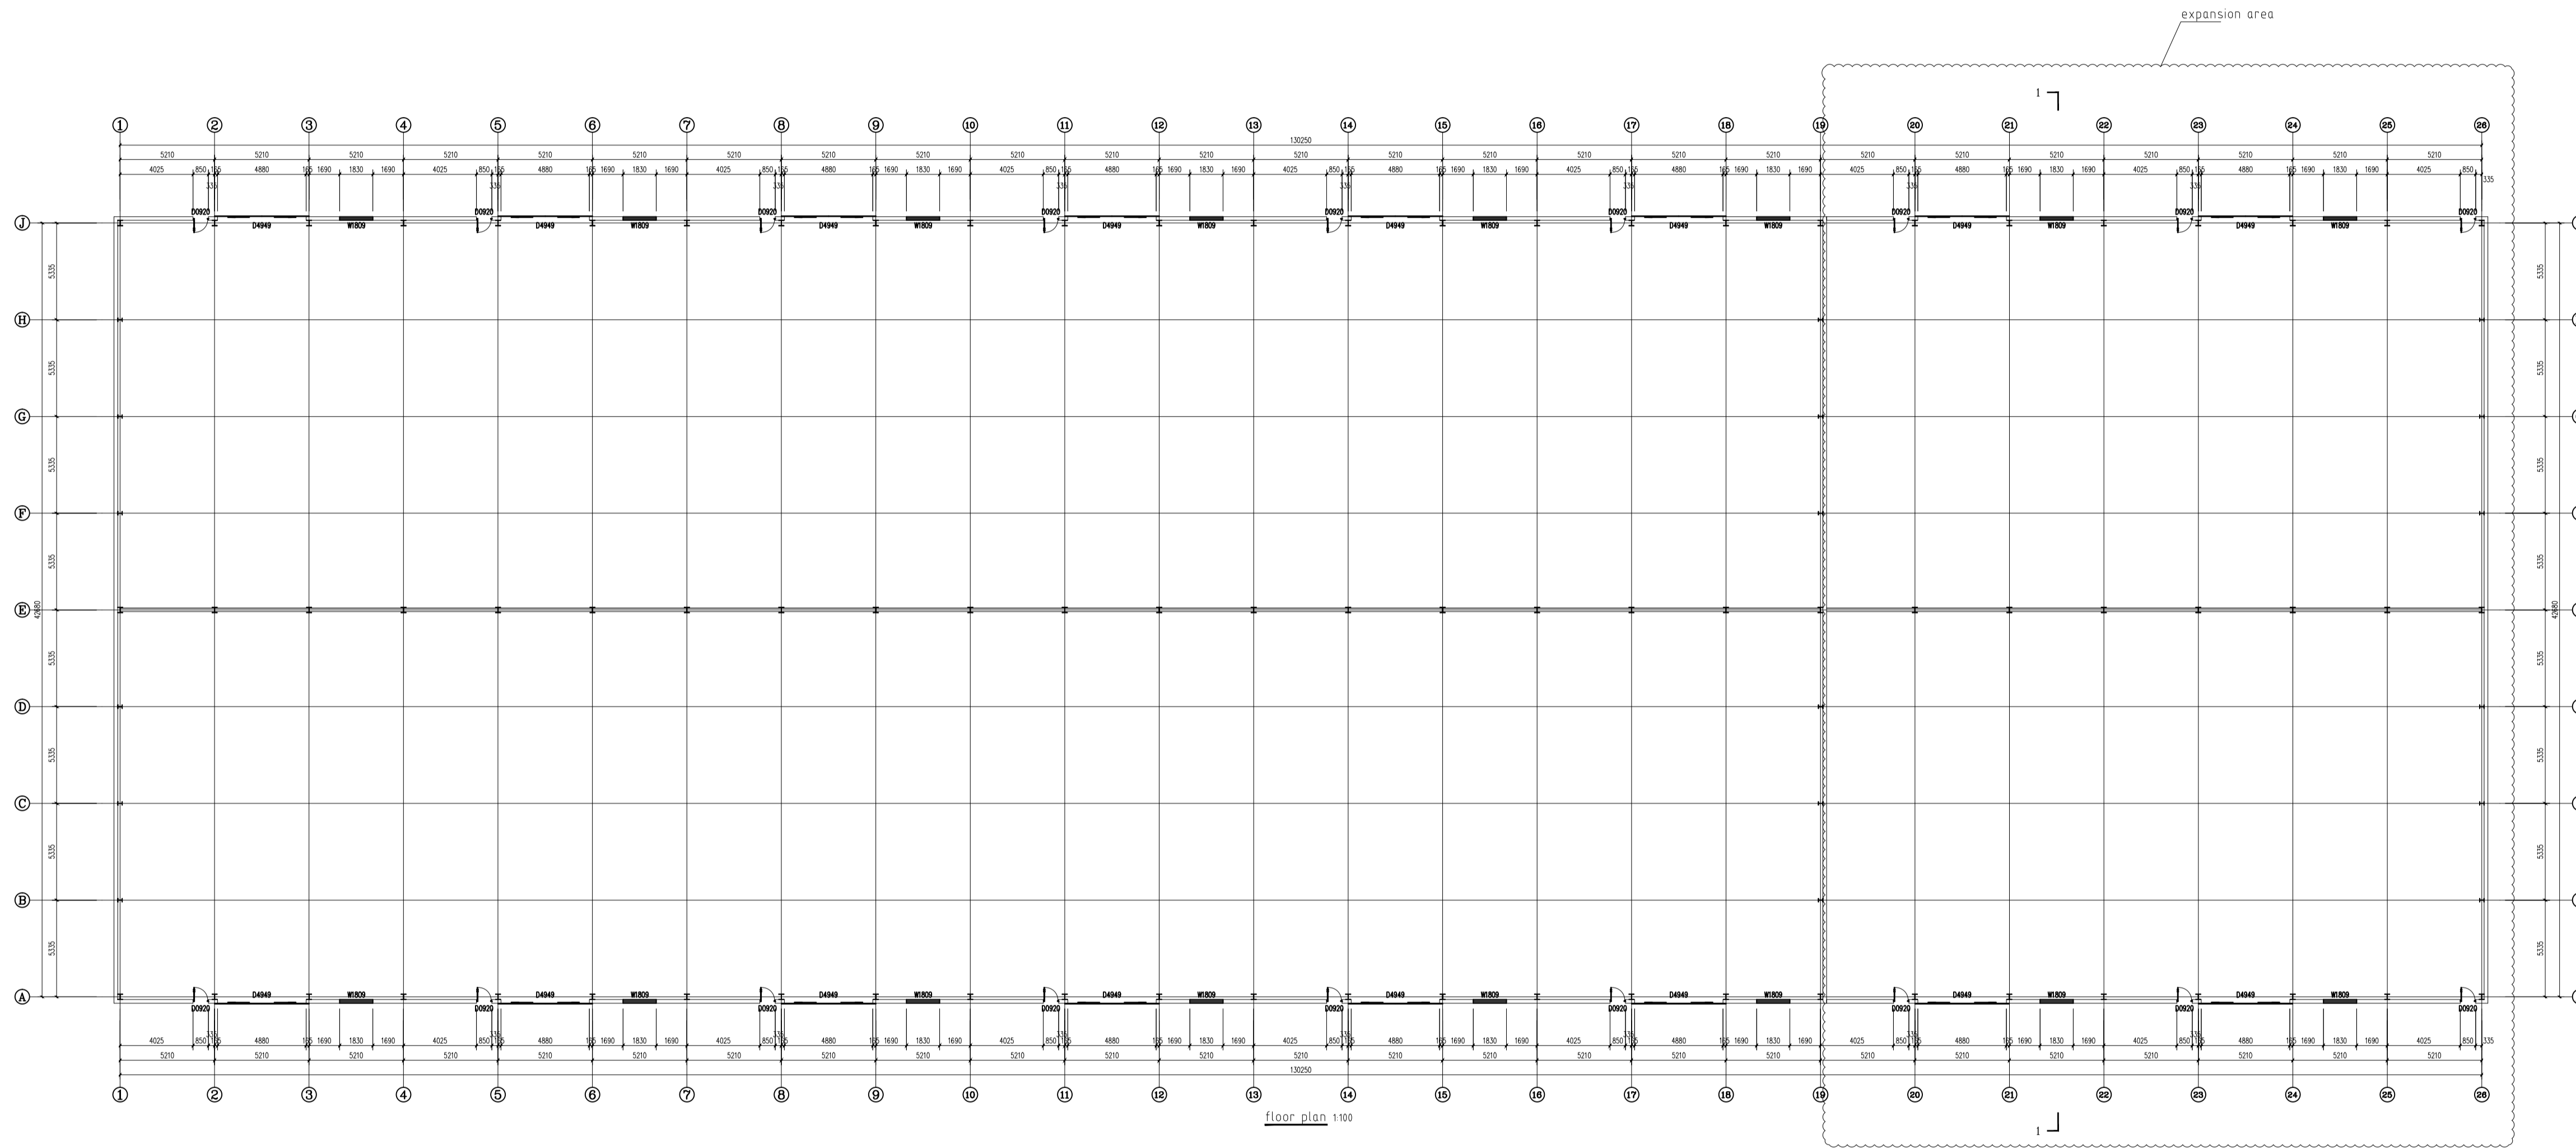

COMPANY STAMP


LICENSE STAMP

CLIENT			
PROJECT	G-Store 2 - expansion		
DRAWING TITLE	floor plan		
PROJECT MANAGER	Marlin	DESIGN NO.	DESIGN
MANAGER	Joe	SPECIALTY	BUILDING
DESIGN	HYH	DATE	2024.07.23
DESIGN NO.	HWB-240723-01	DRAWING NO.	01

SPECIALTY	NAME	DATE	SPECIALTY	NAME	DATE
BUILDING STRUCTURE			HEATING AND VENTILATION		
WATER SYSTEM			ELECTRIC		
			PLUMBING		

LIDA GROUP
 Wefang Henglida Steel Structure Co., Ltd.
 Add: 5th Floor, Building A, Barron Center,
 NO.100, Haier Road, Qingdao City, 266000, China.
 TEL: 86-532-8996982 FAX: 86-532-8996571
 WEBSITE: www.lidajituan.com

Remarks:
 1. All rights of the figure reserved for my company, no modification will be allowed without our company's written authorization.
 2. All the design, conception and information of the figure will only be applied for designated project, no other application will be allowed without our company's written authorization.
 3. The figure can be used as manufacture bases only after the review and approval by the relevant management department.

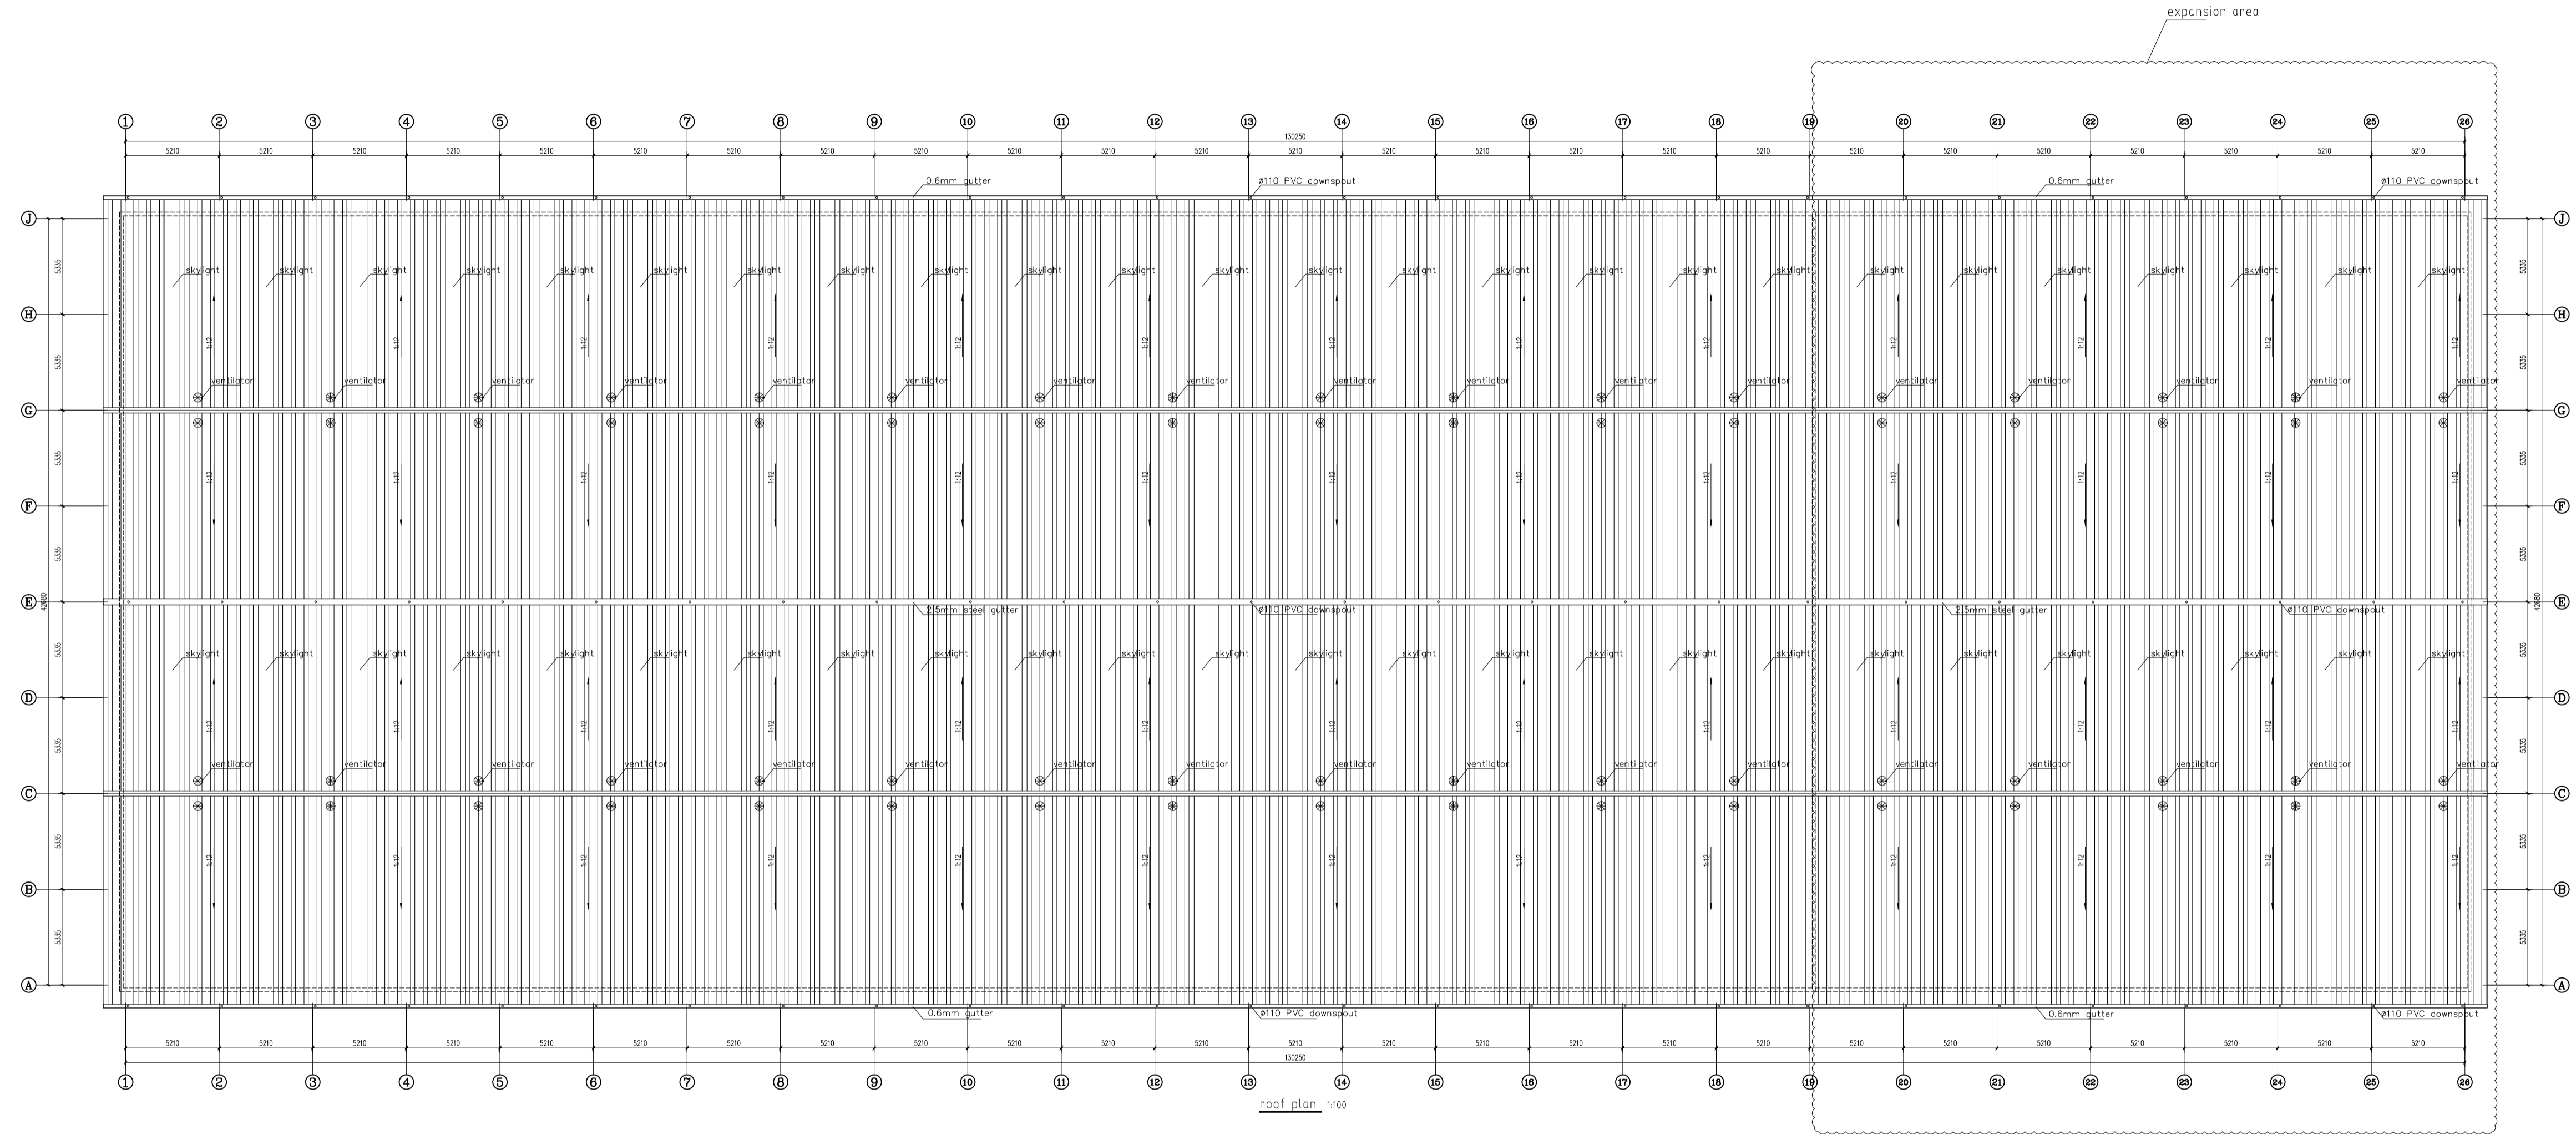

COMPANY STAMP

LICENSE STAMP

CLIENT	
PROJECT	G-Store 2 - expansion
DRAWING TITLE	roof plan
PROJECT MANAGER	Marlin DESIGN NO. DESIGN
MANAGER	Joe SPECIALTY BUILDING
DESIGN	HYH DATE 2024.07.23
DESIGN NO.	HWB-240723-01 DRAWING NO. 02

